

**GLYNN COUNTY STADIUM
SITE WORK**

ADDENDUM NO. 3

John A. Tuten & Associates, Inc.
4680 Hwy 17 North
Brunswick, GA 31525

DATE: May 1, 2018

GENERAL

1. Site clearing and compaction and establishing a building pad for the new field house at elevation 11.68' is a part of the scope of the work of the site contract.

DRAWINGS

1. SHEET C3.1 – ENLARGED GRADING AND DRAINAGE PLAN

- A. Drainage structures D15 and D16 and the connecting piping and drainage structures D17 and D18 and connecting piping and the associated work are part of Alternate No. 1.

2. SHEET C4.1 – ENLARGED UTILITY PLAN


- A. Attached “Sketch – Sanitary Sewer Clarification” dated 4/26/18 is part of Sheet C4.1 showing rim elevation for the new sanitary sewer manhole.

END OF ADDENDUM NO. 3

Attachments:

Sketch

1708SiteWork\160\180501AddendumNo3

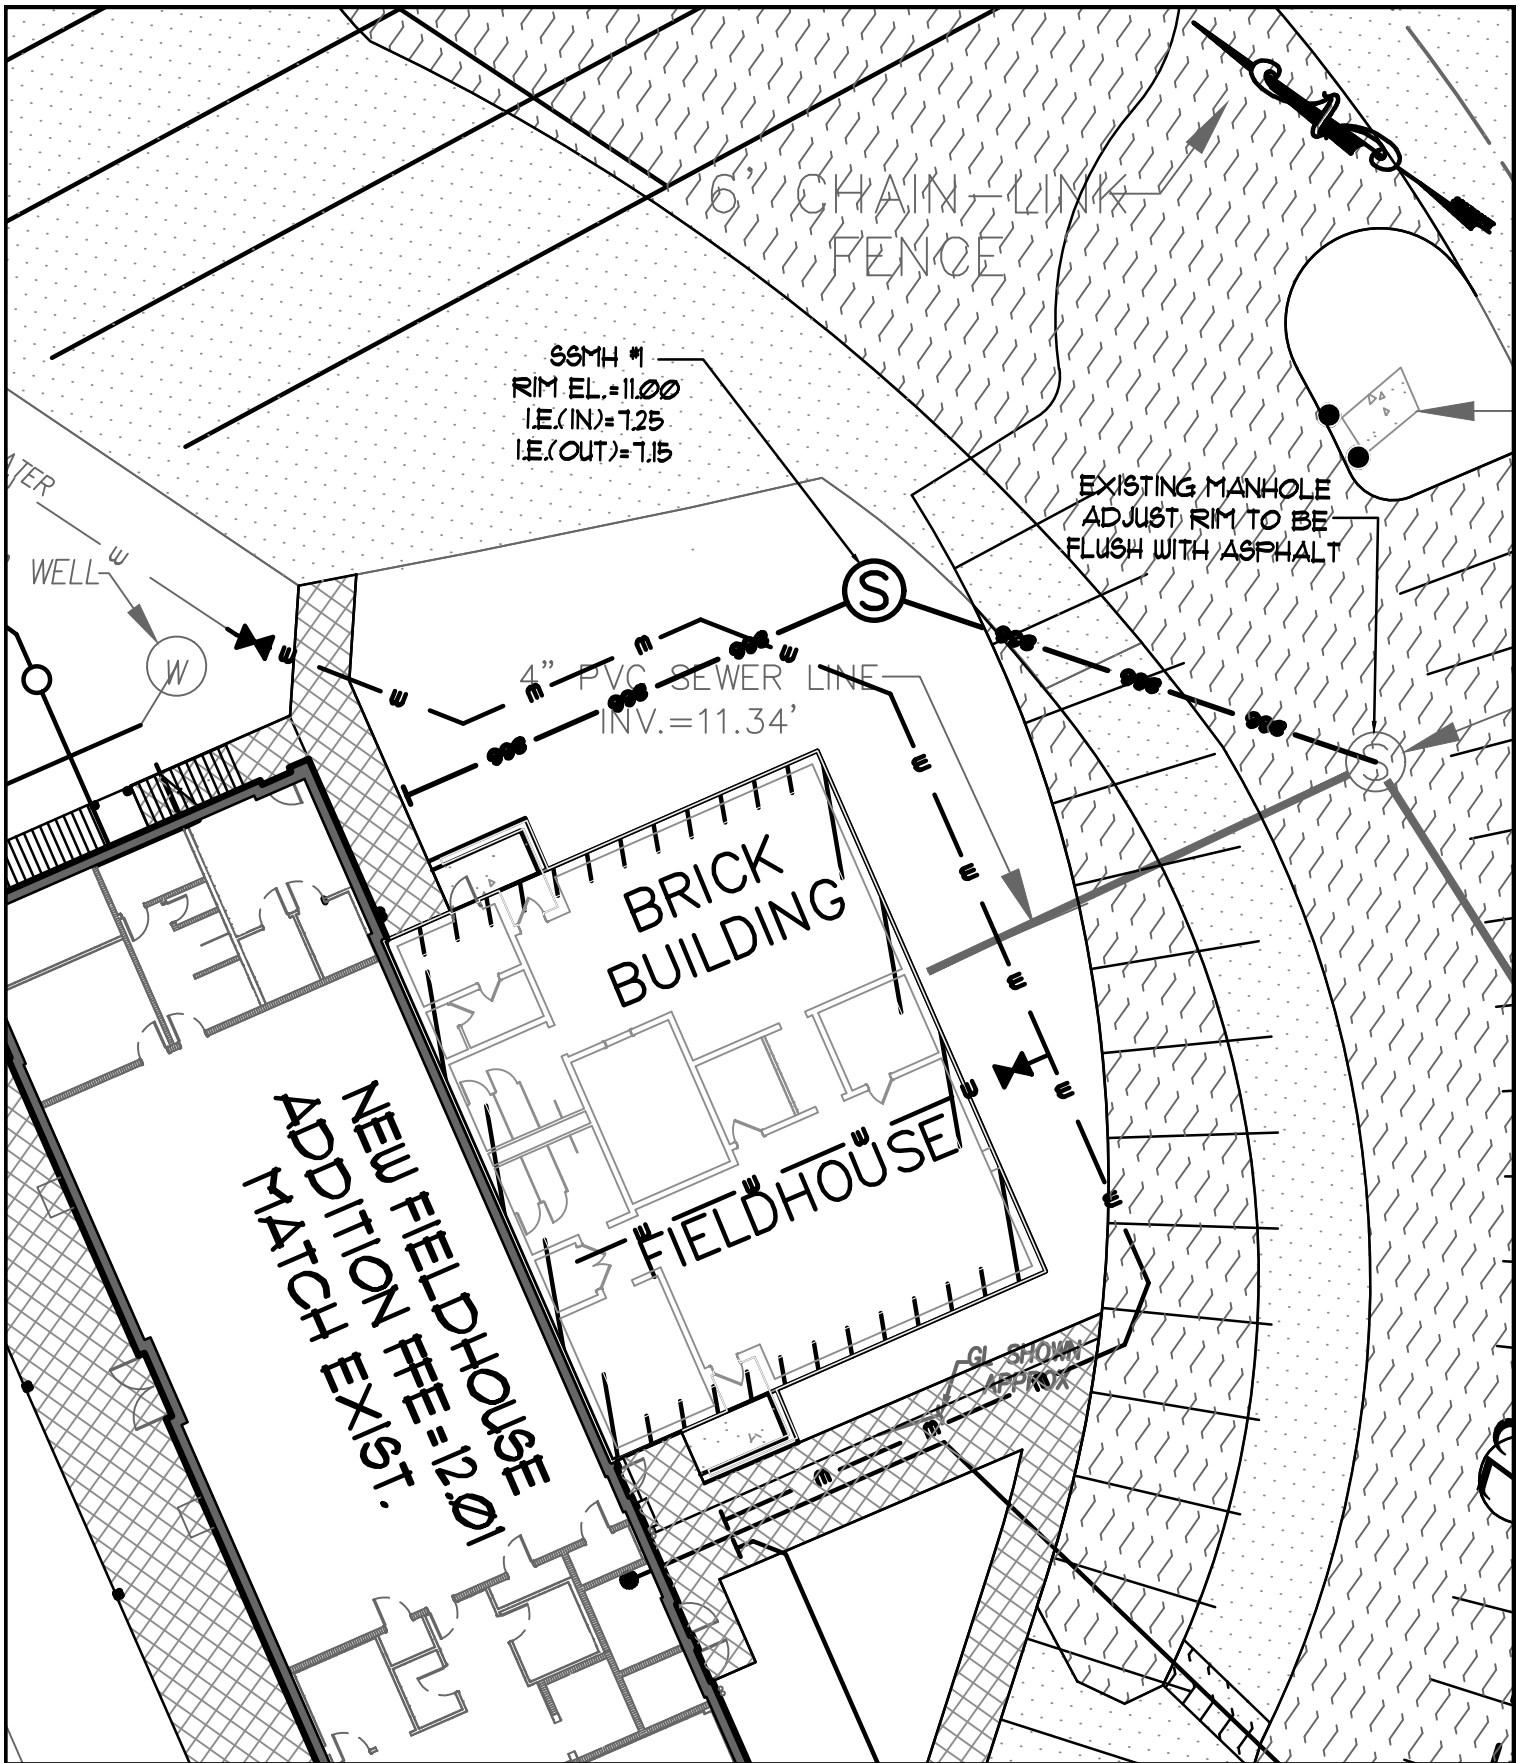

GLYNN COUNTY FIELDHOUSE ADDITION
SANITARY SEWER CLARIFICATION

JAMES W. BUCKLEY & ASSOCIATES, INC. - ARCHITECTS, CIVIL ENGINEERS

DRN. CDS
 CHK. JJS
 1708
 4/26/18

SHEET NO.
